


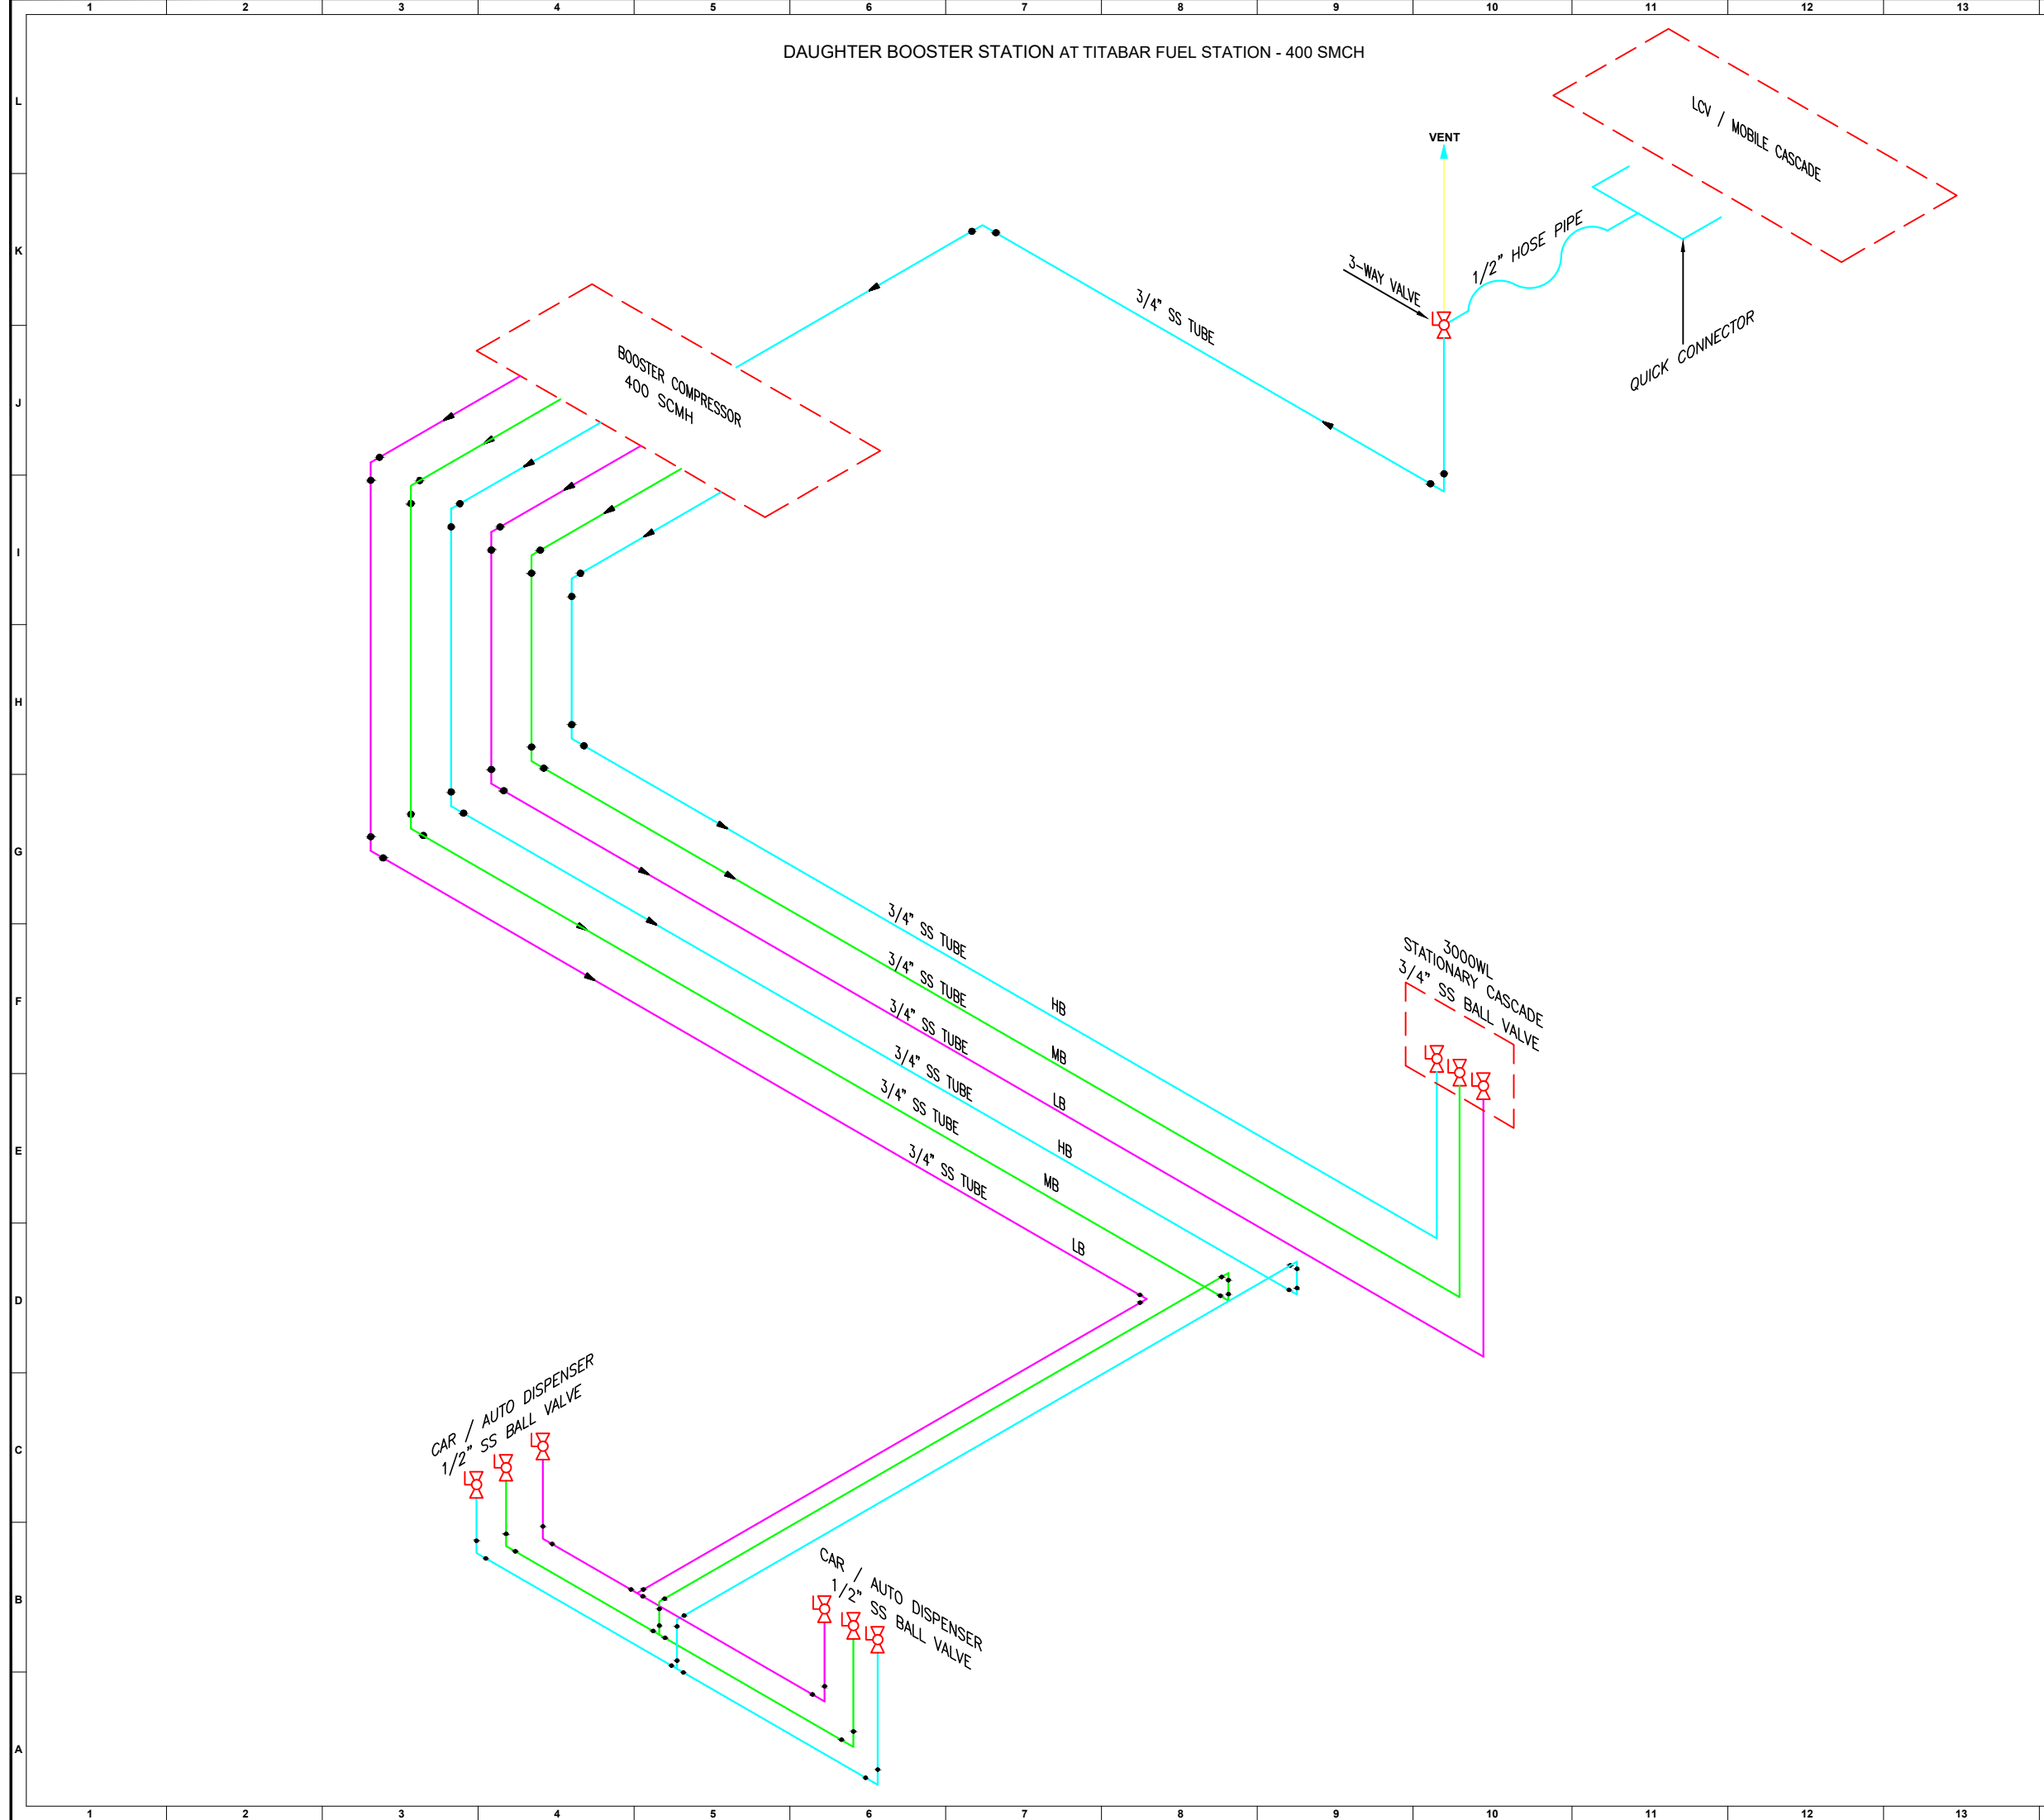

REFERENCE DRAWINGS

DRAWING TITLE	DRAWING NUMBER

CA	27.02.23	ISSUED FOR CLIENT REVIEW	SKU	GST	AD
REV	DATE	DESCRIPTION	BY	CHKD	APPD

OWNER:

ASSAM GAS COMPANY LTD
(A GOVT. OF ASSAM UNDERTAKING)

ENGINEERING CONSULTANT :

PIPELINE ENGINEERING CONSULTANTS PVT. LTD.

PROJECT:

DEVELOPMENT OF CNG STATION / RETAIL OUTLET AT ASSAM

DWG. TITLE :

TYPICAL P&ID DAUGHTER BOOSTER STATION 400 SCM/H AT TITABAR FUEL STATION

SCALE:	JOB NO.	DRAWING NUMBER	REV.
NTS	P117	P117-00-PID-T014	CA
SHEET	1 OF 1		

SHEET SIZE : A1 (841 mm x 594 mm)